


CLIENT
1000165428 ONTARIO INC.
 CITY FILE SP38-19

COPYRIGHT
 This drawing has been prepared solely for the intended use, thus any reproduction or distribution for any purpose other than authorized by Arcadis is forbidden. Written dimensions shall have precedence over scaled dimensions. Contractors shall verify and be responsible for all dimensions and conditions on the job, and Arcadis shall be informed of any variations from the dimensions and conditions shown on the drawing. Shop drawings shall be submitted to Arcadis for general conformance before proceeding with fabrication.

Arcadis Professional Services (Canada) Inc.
 formerly (B) Group Professional Services (Canada) Inc.

ISSUES

No.	DESCRIPTION	DATE
01	PREPARED FOR ZBA/OFA	2023-08-08
02	REVISED PER STAFF COMMENTS	2023-11-02

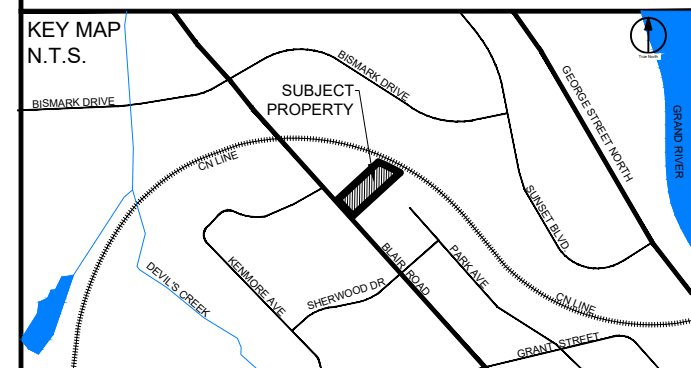

ZONING BY-LAW 150-85

	RM4	REQUIRED	PROVIDED
MIN. LOT FRONTAGE	20m	20m	37.9m
MAX. DENSITY	40 UNITS / ha	40 UNITS / ha	82 UNITS / ha
MIN. FRONT YARD	6.0m	6.0m	6.0m
MIN. INTERIOR SIDE AND REAR YARD	7.5m TO R5 ZONE / 3.0m TO RM4 ZONE	18.7m TO R5 ZONE / 3.0m TO RM4 ZONE	18.7m TO R5 ZONE / 3.0m TO RM4 ZONE
MAX. LOT COVERAGE	40%	40%	18%
MIN. GFA / 2 BEDROOM UNIT	60m²	60m²	>60m²
MIN. COMMON AMENITY AREA / UNIT	30m² / UNIT = 960m²	30m² / UNIT = 960m²	16m² / UNIT (540m²)
MIN. LANDSCAPED AREA	30%	30%	36%
MIN. DISTANCE BETWEEN SIDE WALLS ON SAME LOT	3.0m	3.0m	10.7m
MAX. PERMITTED ENCRoACHMENT - BALCONY	0.6m	0.6m	1.0m
PARKING			
1 SPACE / UNIT + 1 SPACE / 4 UNITS FOR VISITOR	32 x 1.25 = 40	32	38
90° SPACE DIMENSIONS	2.9m x 5.5m AISLE: 6.0m	2.9m x 5.5m AISLE: 6.0m	2.9m x 5.5m AISLE: 6.0m
PARALLEL SPACE DIM.S	2.9m x 6.5m AISLE: 5.0m	2.9m x 6.5m AISLE: 5.0m	2.9m x 6.5m AISLE: 6.0m
ACCESSIBLE TYPE A	3.4m x 5.5m	3.4m x 5.5m	3.4m x 5.5m
ACCESSIBLE TYPE B	2.9m x 5.5m	2.9m x 5.5m	2.9m x 5.5m

LANDUSE

DESCRIPTION	AREA (m²)	# UNITS
BUILDING FOOTPRINT	698.0	32
HARD SURFACE	1,775.9	-
LANDSCAPED	1,411.0	-
TOTAL	3,884.9	32




PROJECT
220 & 222 BLAIR ROAD
 LOT 4, REGISTERED PLAN D1, CITY OF CAMBRIDGE

PROJECT NO:
 139353
 DRAWN BY: _____ CHECKED BY: **M.P.**
 E.T.
 PROJECT MGR: _____ APPROVED BY: **V.L.**
 V.L.

SHEET TITLE
SITE PLAN

SHEET NUMBER **SP01** ISSUE **01**

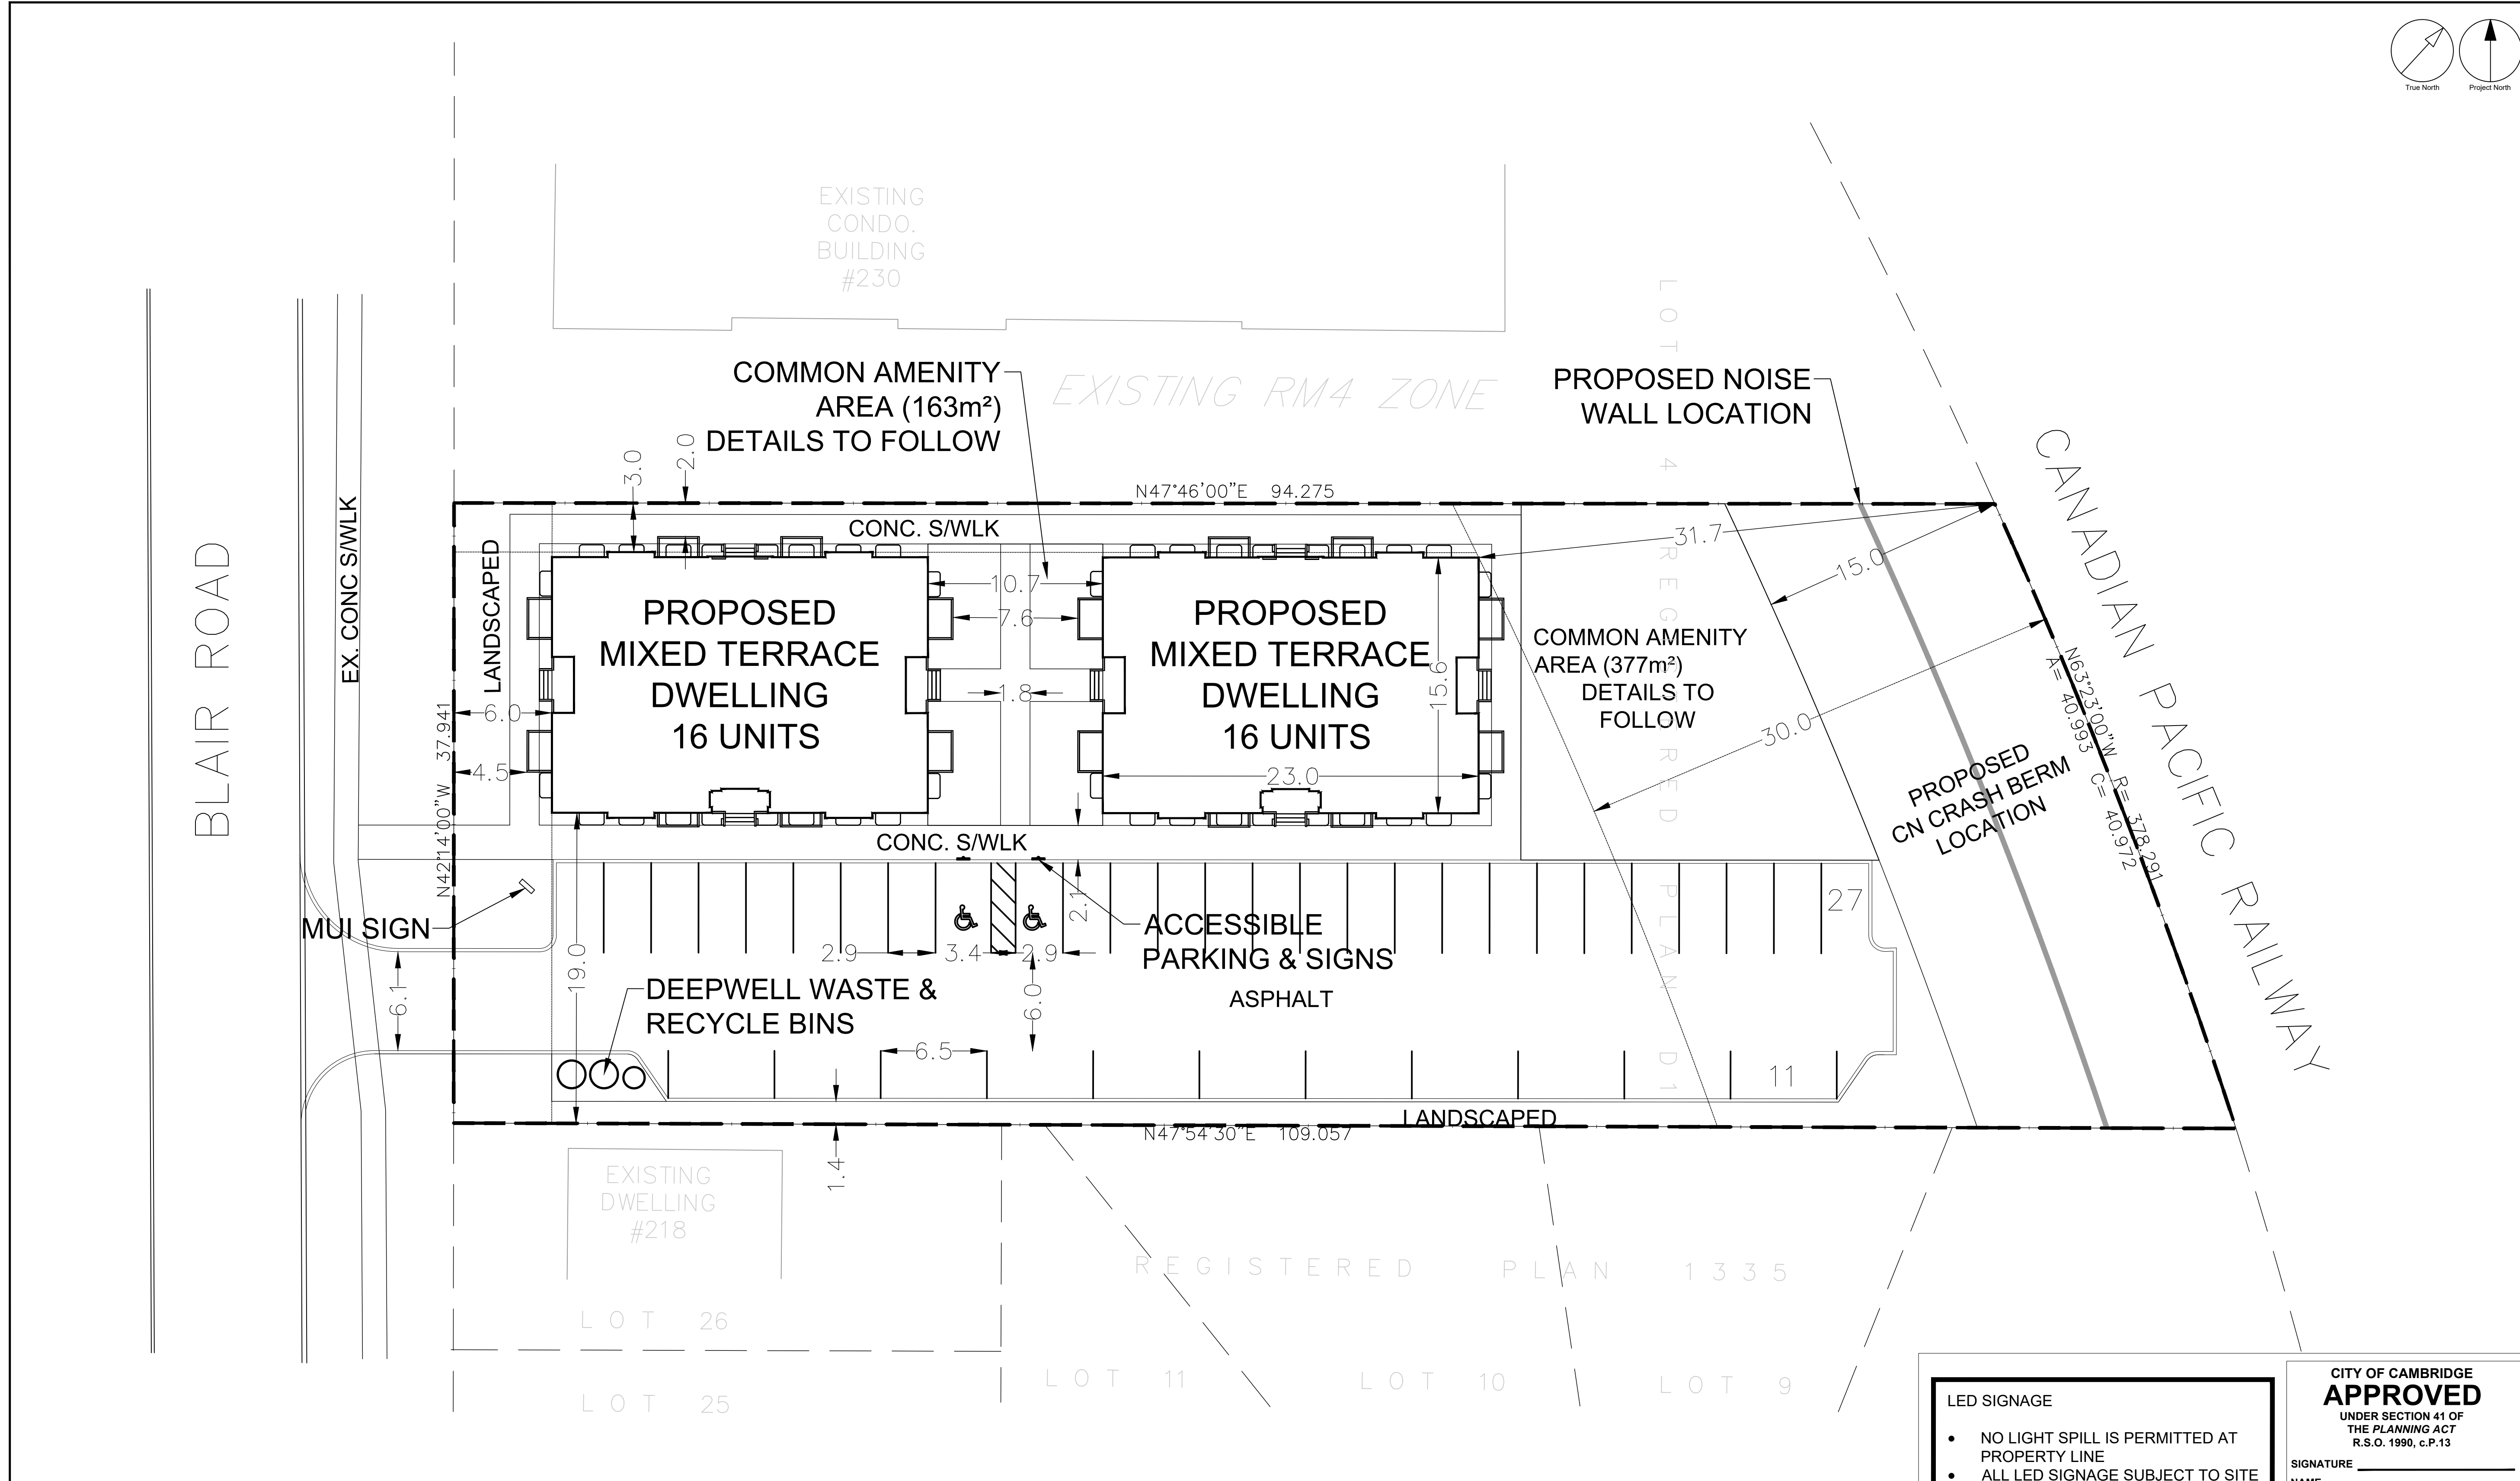

LED SIGNAGE

- NO LIGHT SPILL IS PERMITTED AT PROPERTY LINE
- ALL LED SIGNAGE SUBJECT TO SITE PLAN/LIGHTING PLAN REVIEW

ENERGY + INC.

ALL STRUCTURES AND FIXTURES TO MEET ELECTRICAL SAFETY AUTHORITIES MINIMUM STANDARDS AND CLEARANCES.

CONTACT ENERGY + MINIMUM 6 MONTHS PRIOR TO ANY RELOCATIONS. SERVICE UPGRADE OR NEW IN SERVICE DATE, FOR A DESIGN AND ESTIMATE, WITH ALL OF THE INFORMATION ENERGY + REQUIRES TO PREPARE AS PER ENERGY +'S CONDITIONS OF SERVICE WWW.ENERGYPLUS.CA

CITY OF CAMBRIDGE APPROVED
 UNDER SECTION 41 OF THE PLANNING ACT R.S.O. 1990, c.P.13

SIGNATURE _____
 NAME _____
 TITLE _____
 DATE _____

SITE PLAN IS RECOMMENDED FOR APPROVAL

BUILDING DIV. _____
 ACCESSIBILITY _____
 ECON. DEV. _____
 DEV. ENG. _____
 FIRE DEPT. _____
 HYDRO _____
 TRANSPORTATION _____
 PLANNING _____
 REGION OF WATERLOO _____

File Location: \\139353_220-222_Blair7.dwg Production\7_03_Design\7_Planning\Sheets\139353_SP.dwg
 Last Saved: November 2, 2023, 1:55:46 PM by Emma Tilley
 Project: Wednesday, November 29, 2023, 1:55:46 PM by Emma Tilley